


SHOALS ENGINEERING, PC

1138 N. WOOD AVE.
FLORENCE, ALABAMA, 35630
TEL: (256) 764-0817
FAX: (256) 764-0838
PROJECT NO.: 17-1718



ALABAMA HIGHWAY #195 (R.O.W. VARIES)

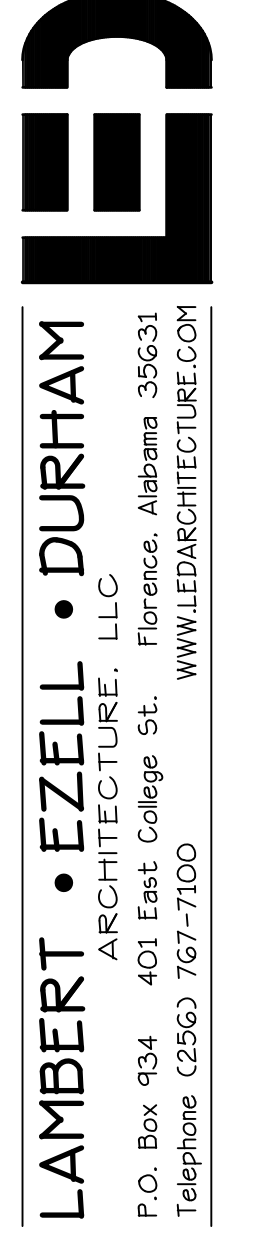

LAMBERT • EZELL • DURHAM
ARCHITECTURE, LLC
P.O. Box 934 401 East College St.
Florence, Alabama 35631
Telephone (256) 767-7100
WWW.LEDARCHITECTURE.COM

Job No. 1612
Drawn RAR/ABL
Checked JBL
Date 11/30/17
Revised
Revised


Drawing Title
ELECTRICAL SITE PLAN
Drawing Number
E-1
OF 8

T

T

T

L

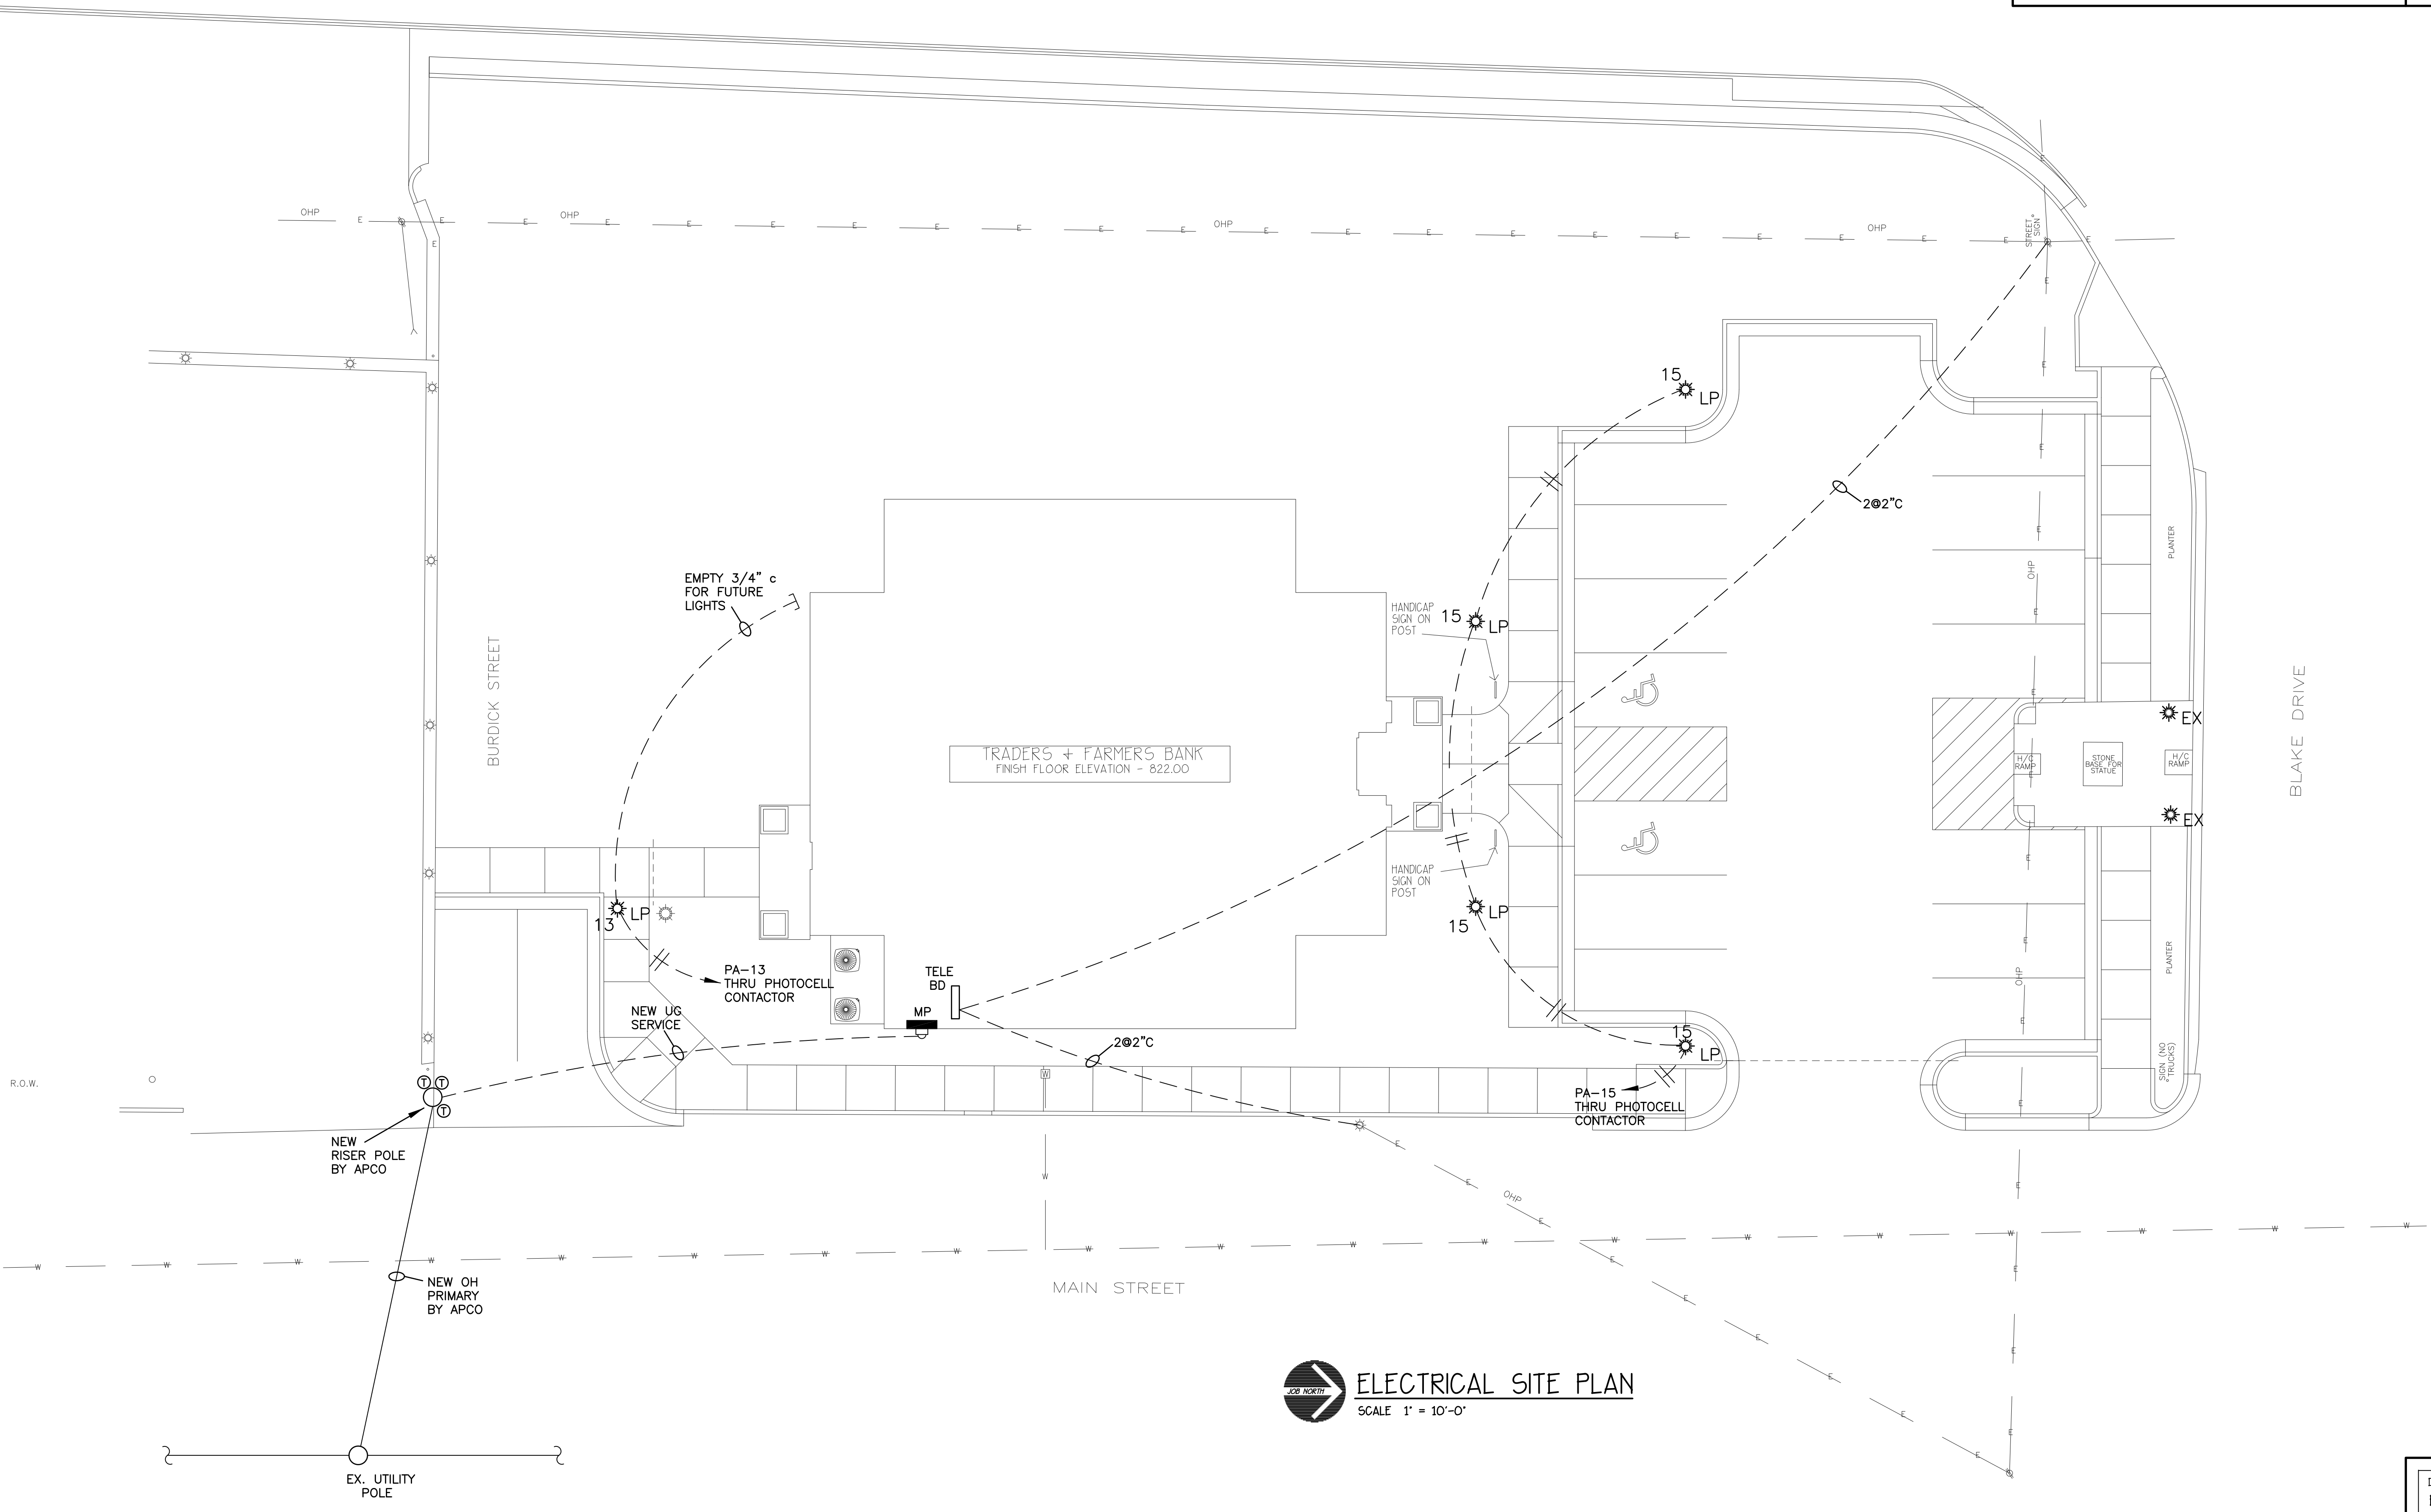

ELECTRICAL SITE PLAN
SCALE 1" = 10'-0"

