


File Name@@DWG\FULLNAME  
 Plot Date@PLTDATE Plot Time@PLTIME

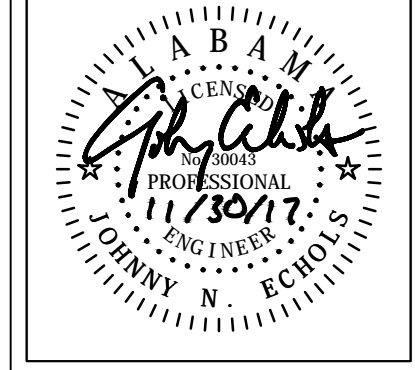

**LAMBERT • EZELL • DURHAM**  
 ARCHITECTURE, LLC  
 P.O. BOX 334 401 EAST COLLEGE ST. FLORENCE, ALABAMA 35631  
 TELEPHONE (256) 761-1100 WWW.LEDARCHITECTURE.COM


BRANCH BANK FOR  
**TRADERS AND FARMERS BANK**  
 DOUBLE STRINGS, ALABAMA

JOB NO.	1612	DATE	11/30/17
DRAWN	IJB	REVISED	
CHECKED	JNE	REVISED	

DRAWING TITLE  
**PLUMBING SITE PLAN**

DRAWING NUMBER  
**P-1.0**

OF 4

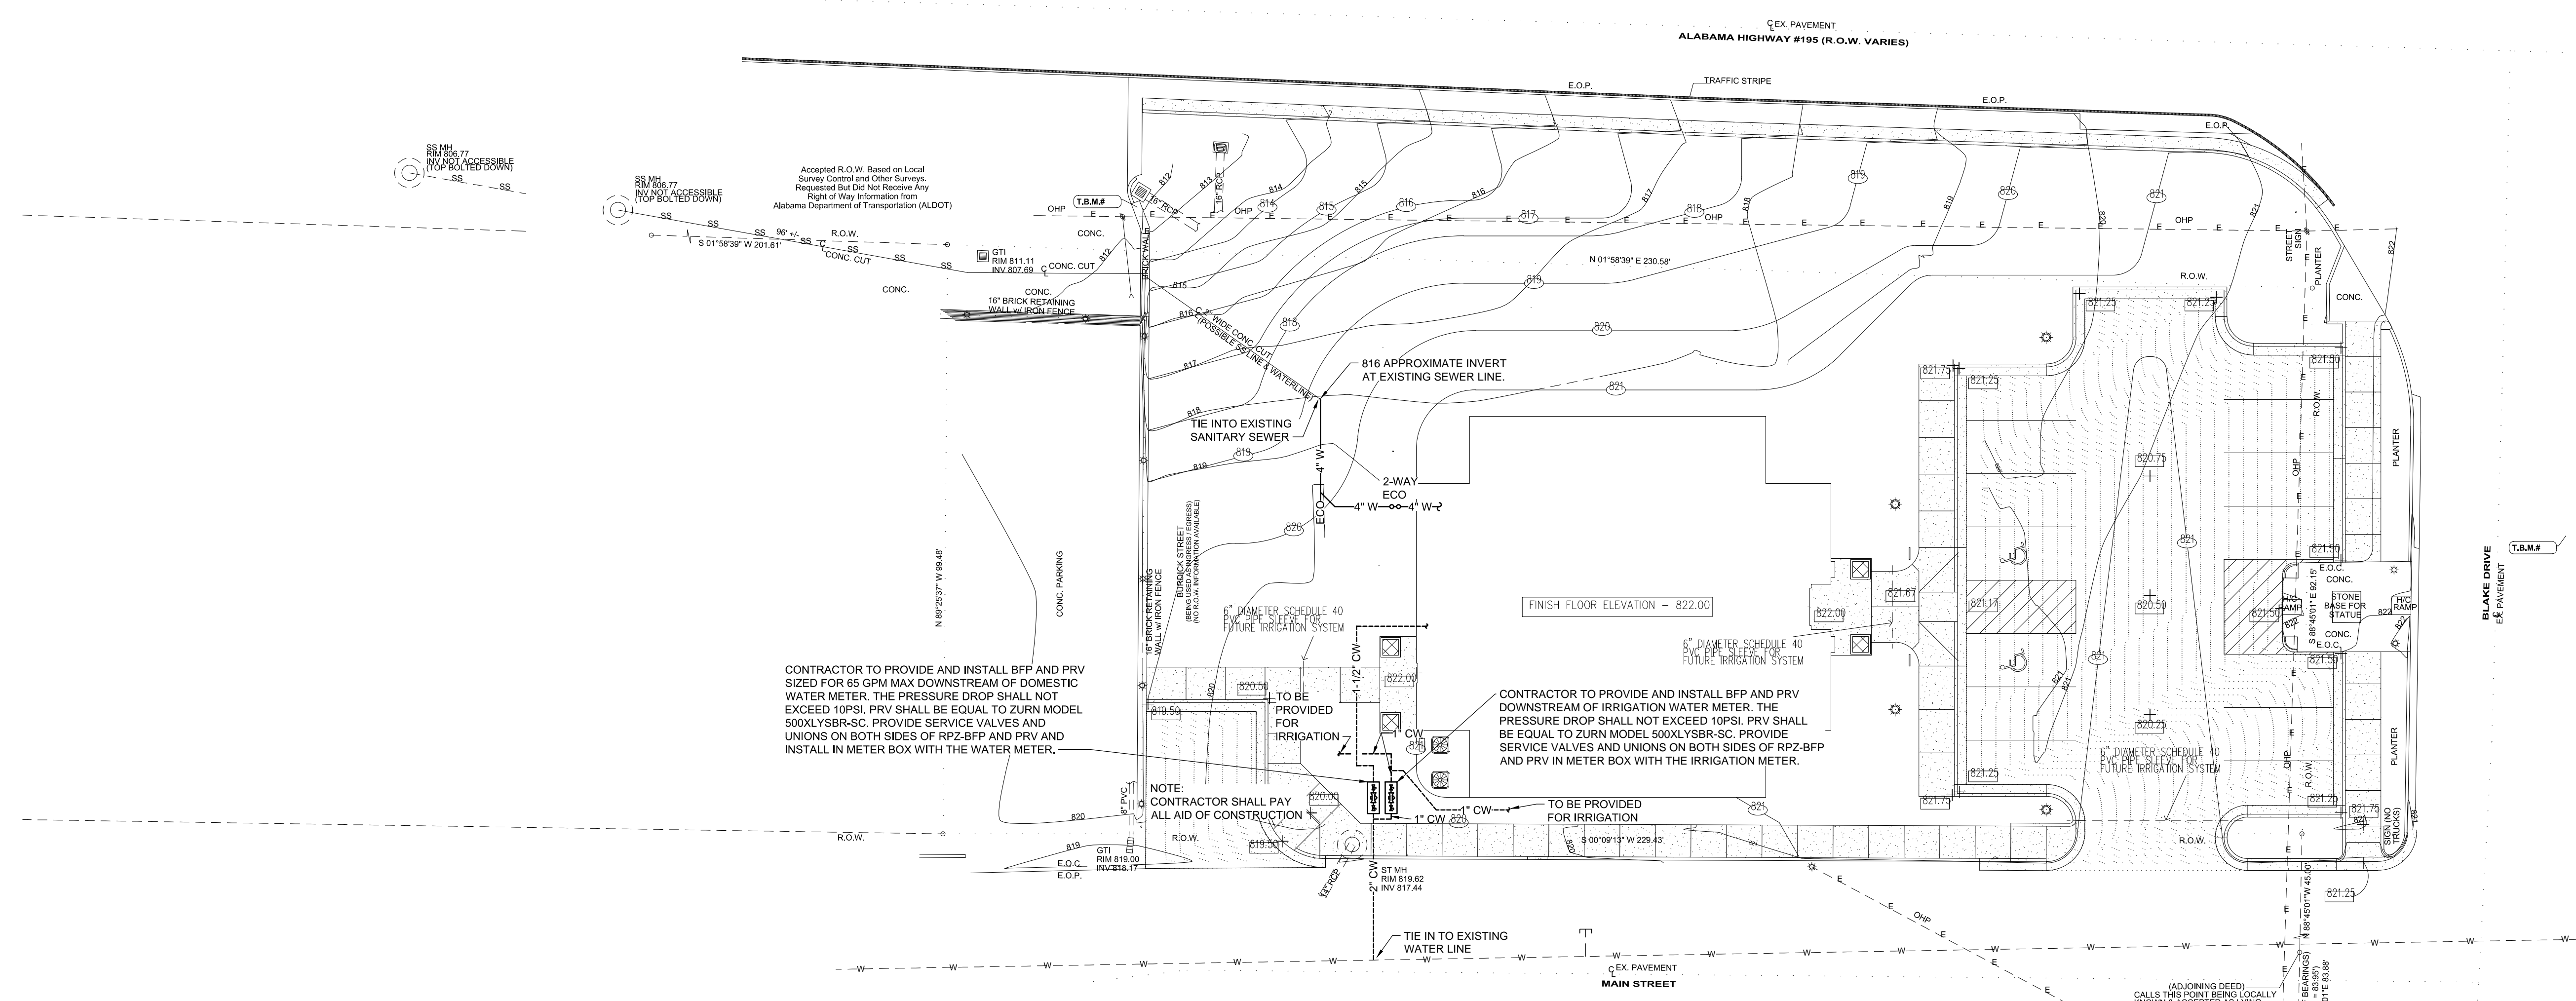

**PLUMBING SITE PLAN**  
 SCALE: 1/16" = 1'-0"

