

GENERAL PLUMBING NOTES

1. THESE DRAWINGS ARE DIAGRAMMATICAL ONLY AND ARE AN INTERPRETATION ON HOW TO INSTALL SYSTEM COMPONENTS AS INTENDED AND SHOWN ON FLOOR PLAN DRAWINGS IN A MANNER TO ELIMINATE CONFLICTS BETWEEN OTHER TRADES AND ALLOW FOR CLEARANCES, ETC. THEY MAY BE REQUIRED TO BE SHIFTED AS DETERMINED BY FIELD CONDITIONS. REFER TO ALL FLOOR PLAN DRAWINGS FOR NOTATIONS, SIZES, ETC. THE DRAWINGS DO NOT SHOW ALL COMPONENTS REQUIRED FOR A COMPLETE INSTALLATION (HANGERS, INSULATION, ETC.). IT IS THE RESPONSIBILITY OF THE CONTRACTOR TO PROVIDE ALL MATERIALS AND LABOR NECESSARY TO INSTALL THE FIXTURES, EQUIPMENT, PIPING, ETC. TO MEET THE INTENT OF THE DRAWINGS. REFER TO ENTIRE CONTRACT DOCUMENT SET FOR ALL COMPONENTS REQUIRED (FLOOR PLAN DRAWINGS, SPECIFICATIONS, SCHEDULES, DETAILS, ETC.).
2. THIS CONTRACTOR IS RESPONSIBLE FOR REVIEWING ALL DRAWINGS AND SPECIFICATIONS OF ALL DISCIPLINES FOR ANY AND ALL WORK THAT WILL IMPACT THIS CONTRACTOR AND WILL BE THE RESPONSIBILITY OF THIS CONTRACTOR TO PROVIDE SAID WORK.
3. CERTAIN AREAS WILL REQUIRE EXTENSIVE COORDINATION BETWEEN ALL TRADES. CONTRACTOR(S) SHALL COORDINATE PRIOR/DURING CONSTRUCTION TO ELIMINATE ANY CONFLICTS.
4. THE BOTTOM OF ALL PIPING TO BE COORDINATED WITH ROOM FINISH SCHEDULE FOR CEILING HEIGHTS AND SHALL BE A MINIMUM OF 6" ABOVE THE CEILING GRID. ALL SERVICEABLE ITEMS SUCH AS EQUIPMENT, VALVES, CIRCUIT SETTERS, ETC. SHALL BE LOCATED NO MORE THAN 24" ABOVE THE CEILING GRID.
5. SLEEVE ALL FOUNDATION WALL PENETRATIONS WITH SCH. 40 SLEEVE 2 PIPE SIZES LARGER THAN SERVICE PIPE.

Fixture Symbol	Type of Fixture	Connection sizes			
		Waste	CW	HW	HWR
P-1	ADA Floor Mount Flush Tank Water Closet	4"	1/2"		
P-2	ADA Lavatory	2"	1/2"	1/2"	
P-3	Bi-level Electric Water Cooler	2"	1/2"		
P-4	Kitchen 2 Compartment Sink	2"	1/2"	1/2"	
P-5	Mop Sink	3"	3/4"	3/4"	
P-6	Icemaker Wall Box				
P-7	Exterior Hydrant		3/4"		
P-8	Water Heater		1-1/4"	1-1/4"	3/4"
P-9	Circulation Pump				1"
P-10	Trench Drain	3"			
P-11	Recessed Floor Drain	3"			
WCO	Wall Cleanout				
ECO	Exterior Cleanout				




Notes:
1. Coordinate mounting height of all wall mounted fixtures with the Architectural Drawings.

PLUMBING SYMBOL LEGEND


- = NEW WORK (EQUIPMENT, PIPE, ETC.)
- = COLD WATER PIPING ABOVE GRADE
- = HOT WATER PIPING ABOVE GRADE
- = HOT WATER RETURN PIPING ABOVE GRADE
- = COLD OR HOT WATER PIPING BELOW GRADE
- = WASTE / RAIN WATER PIPING
- = VENT PIPING

PLUMBING NOTATION LEGEND

- CO = CLEAN OUT
- CW = COLD WATER
- ECO = EXTERIOR CLEANOUT
- HW = HOT WATER
- HWR = HOT WATER RETURN
- W = WASTE

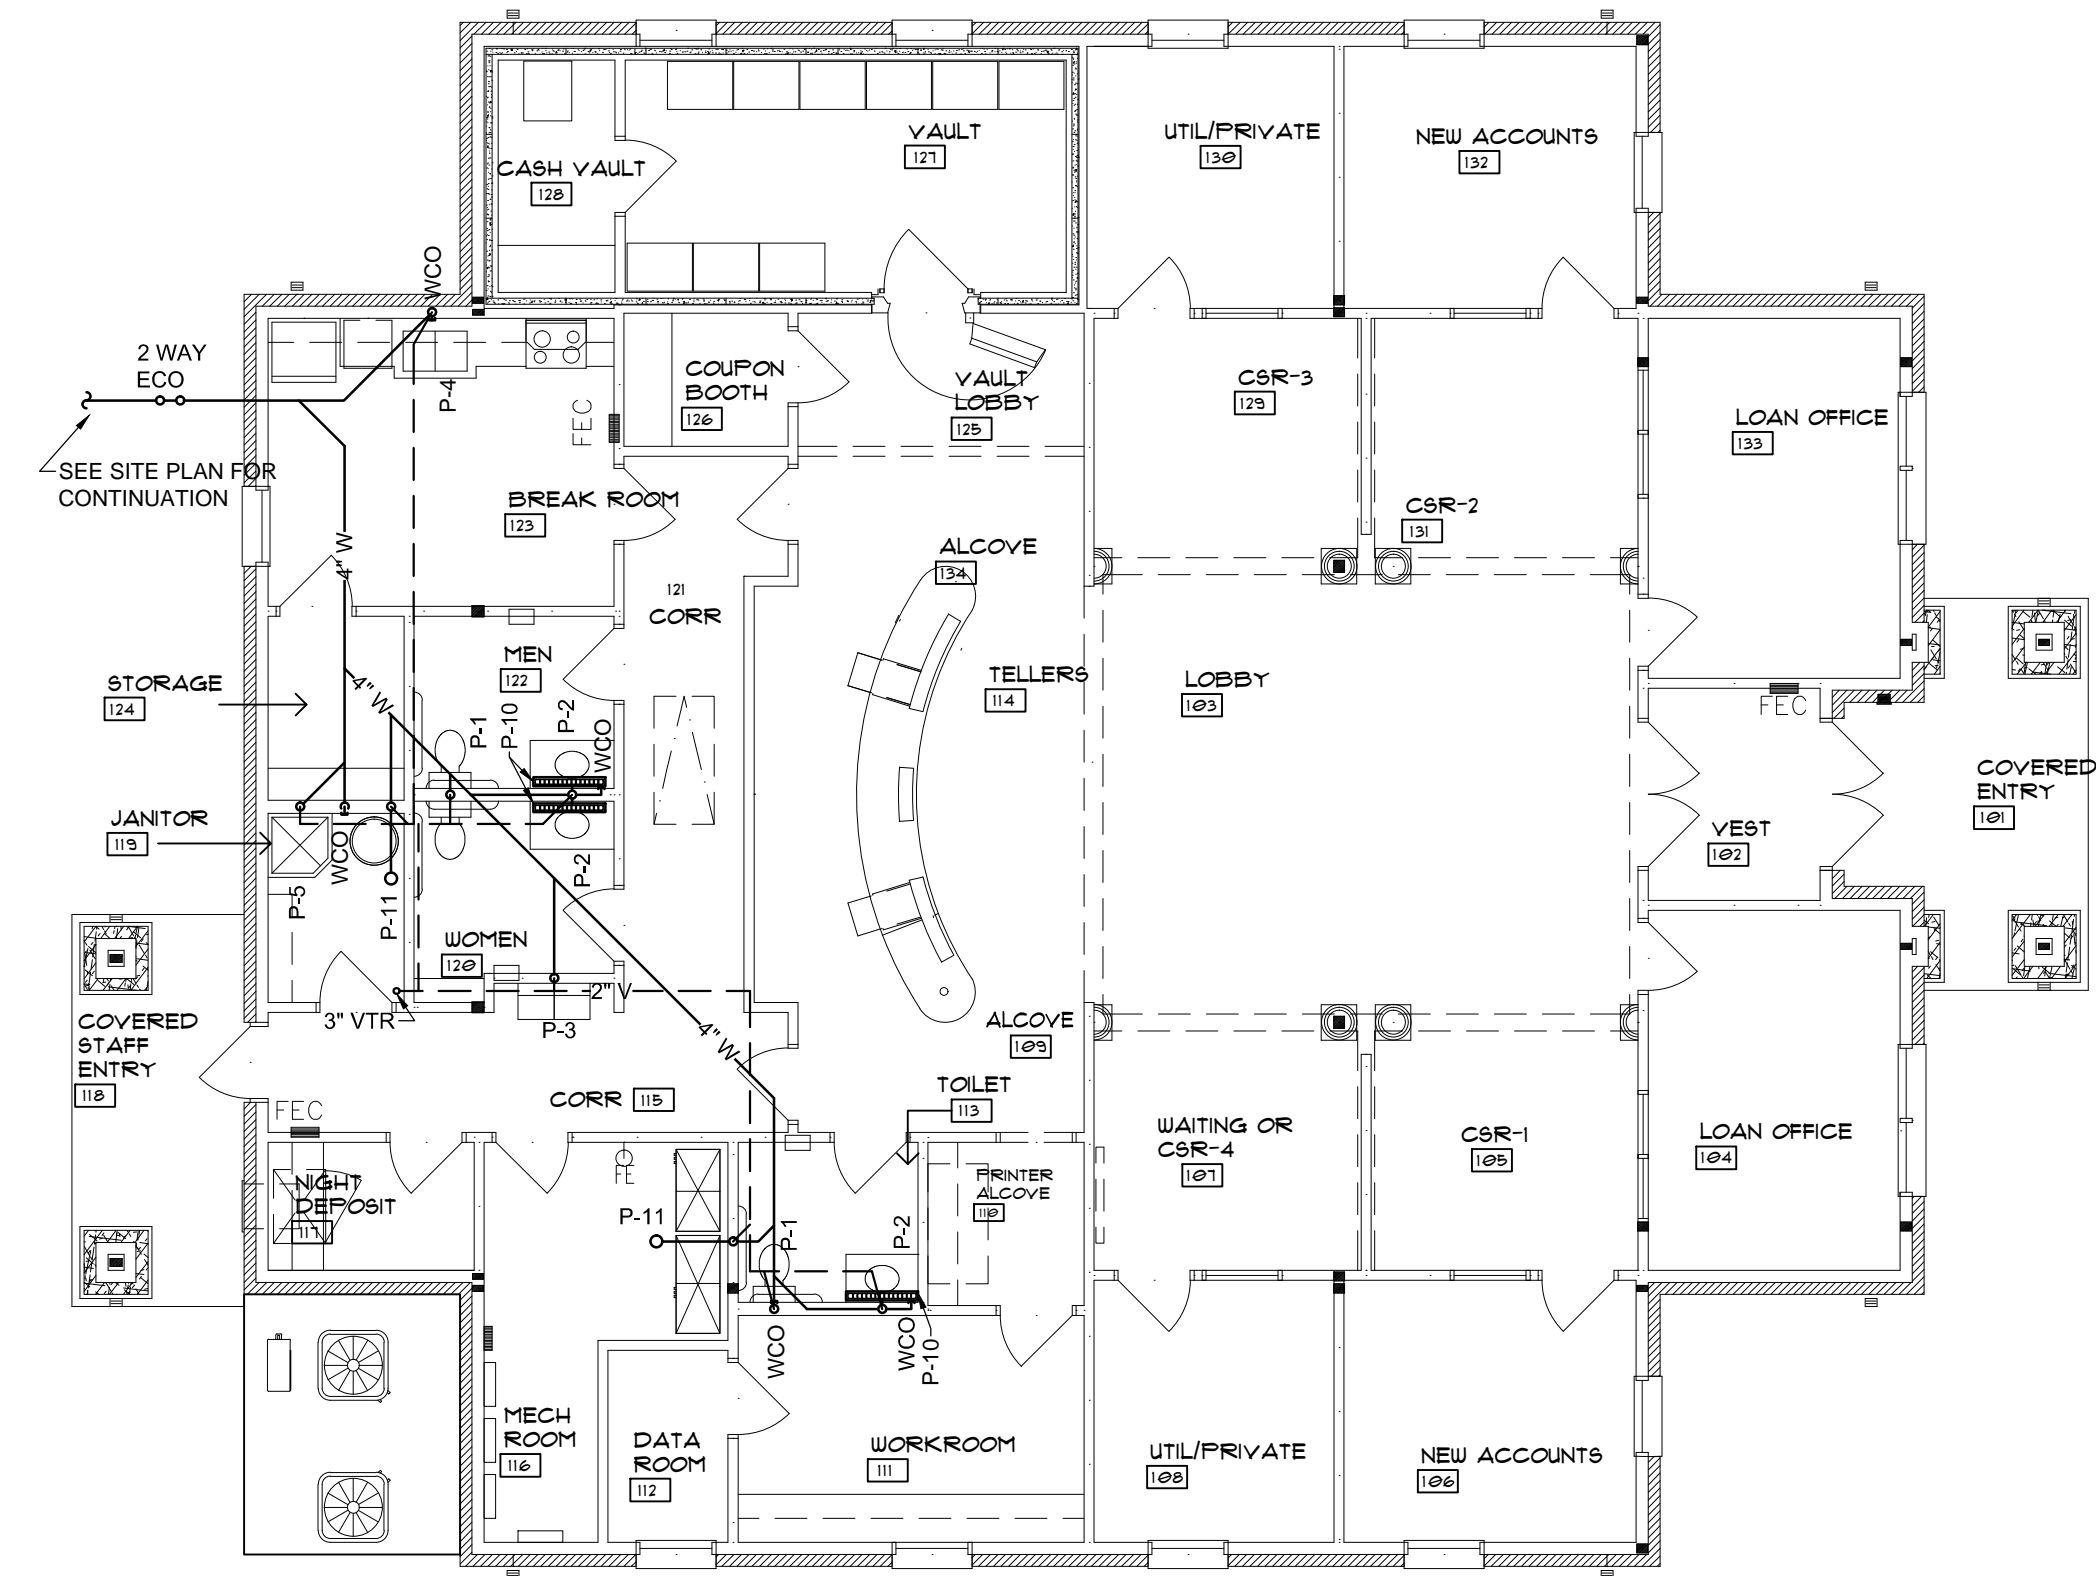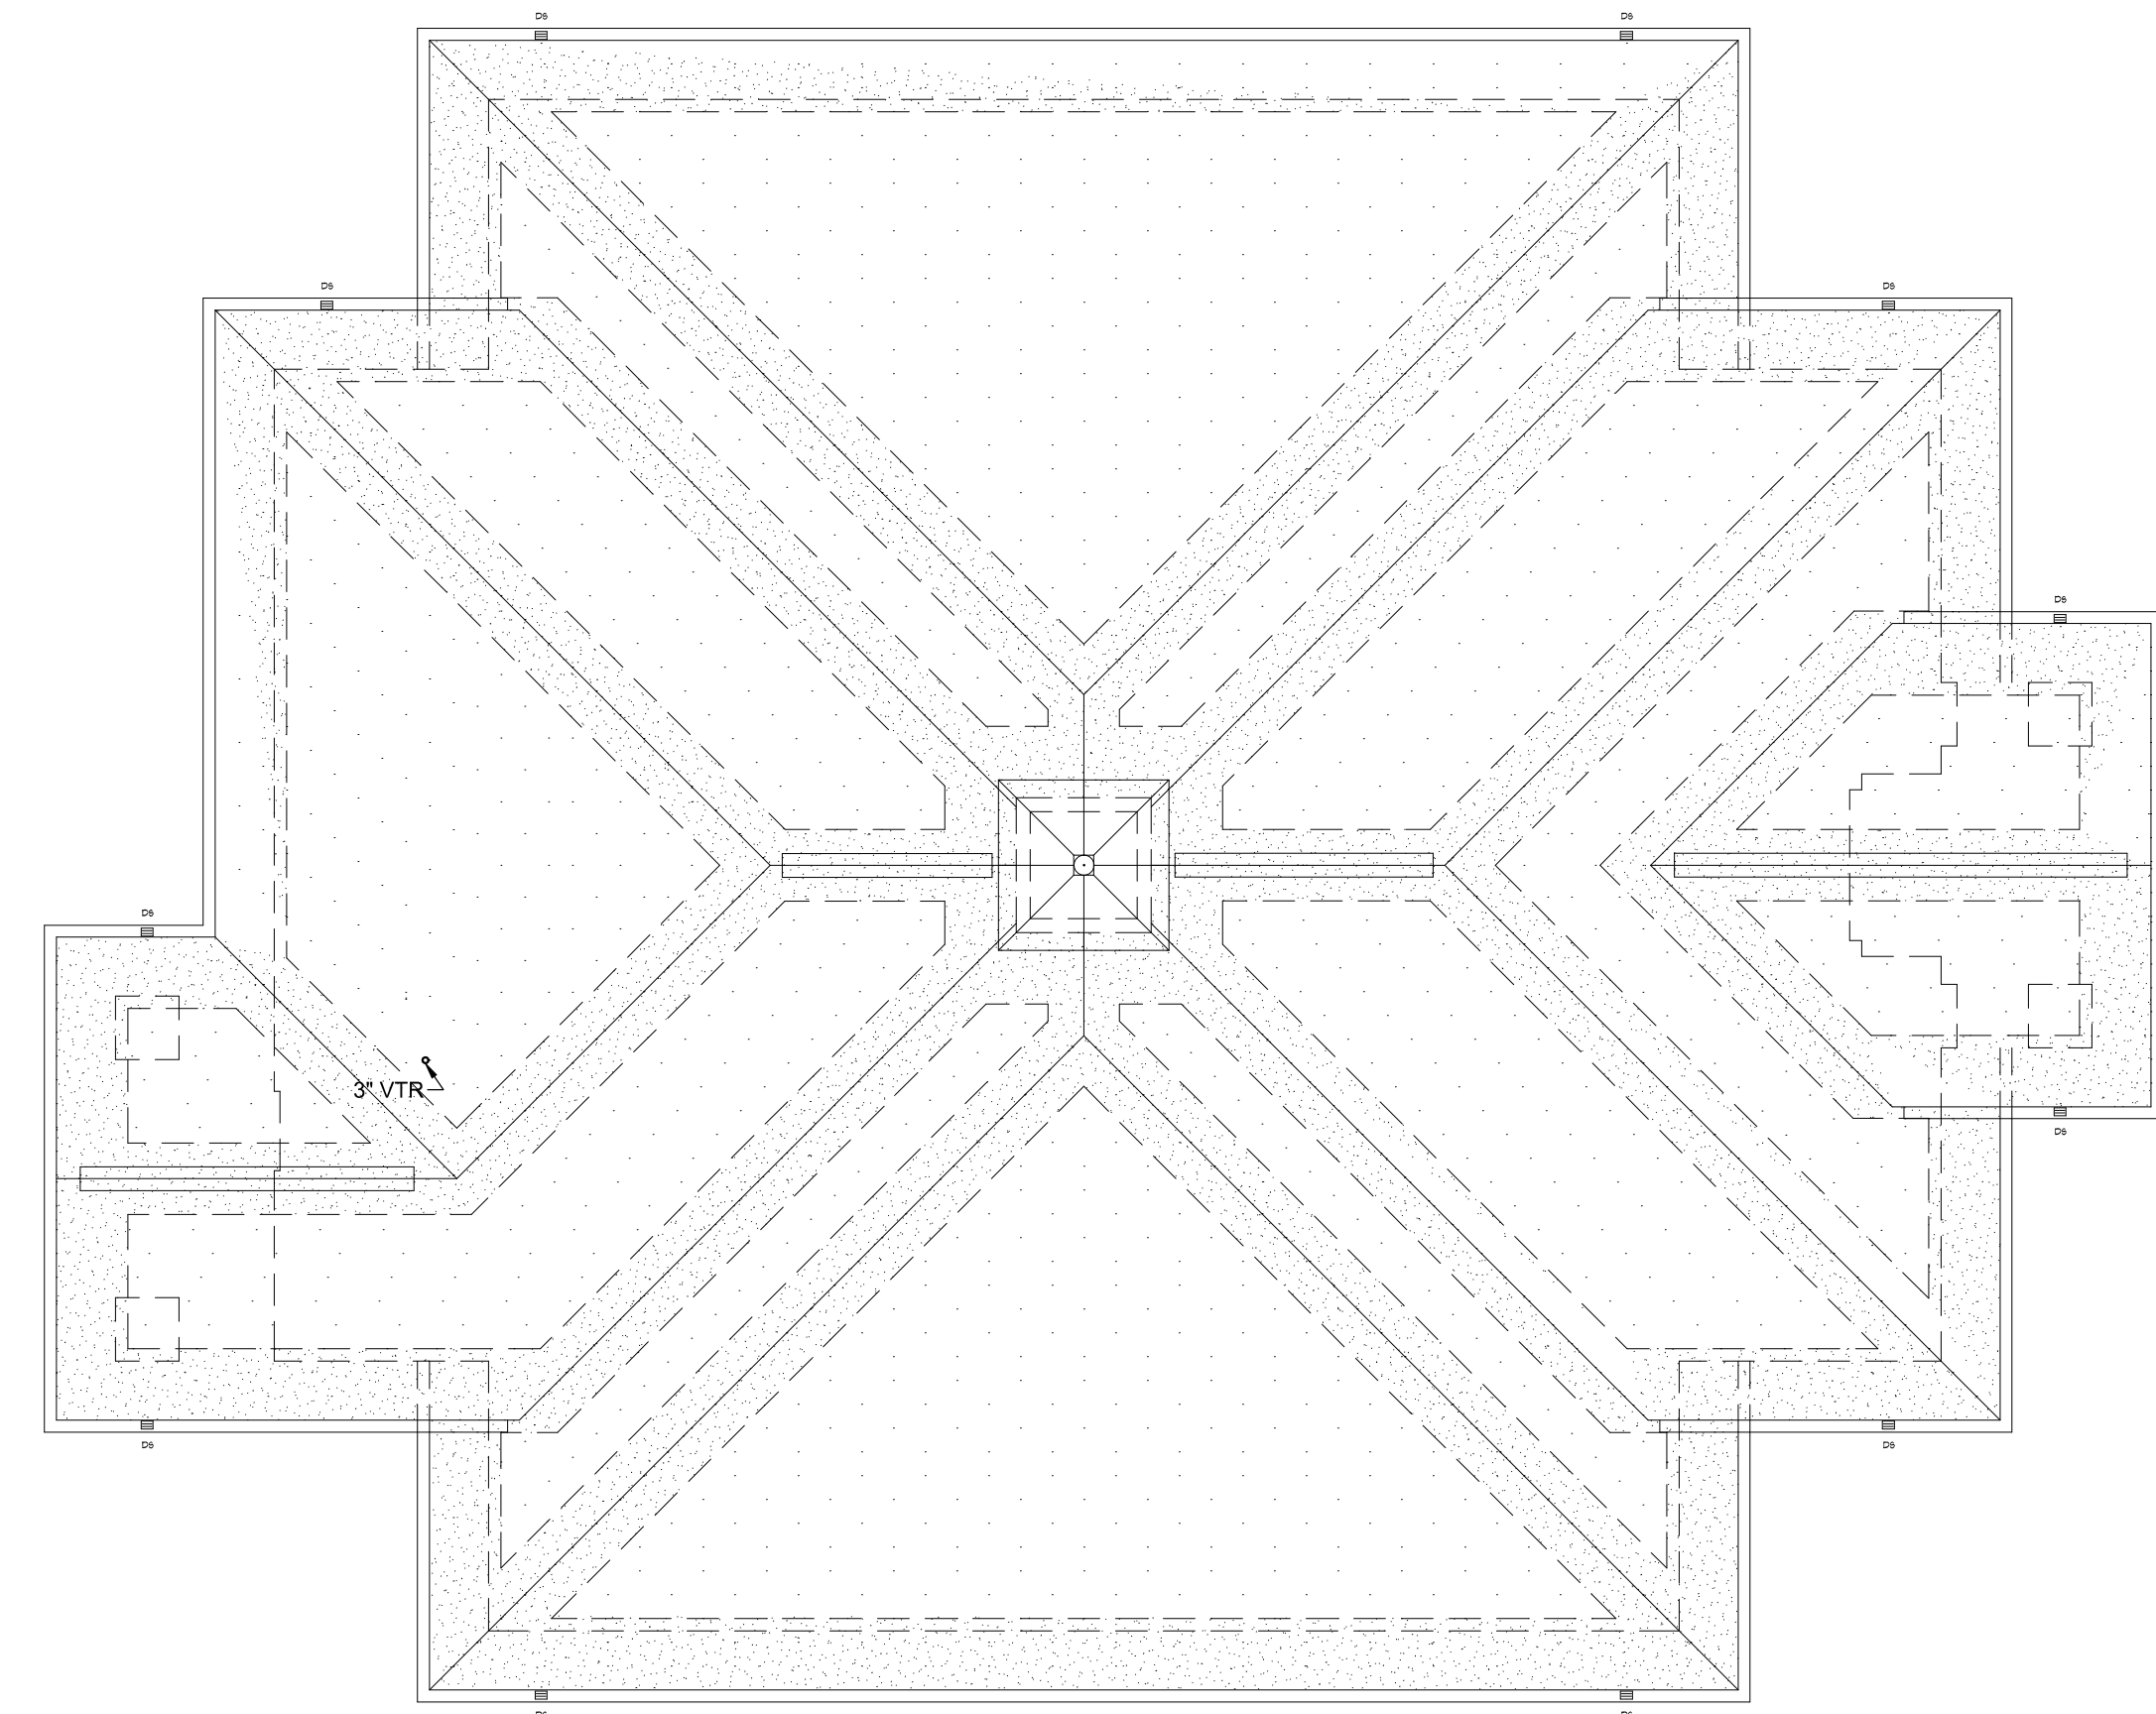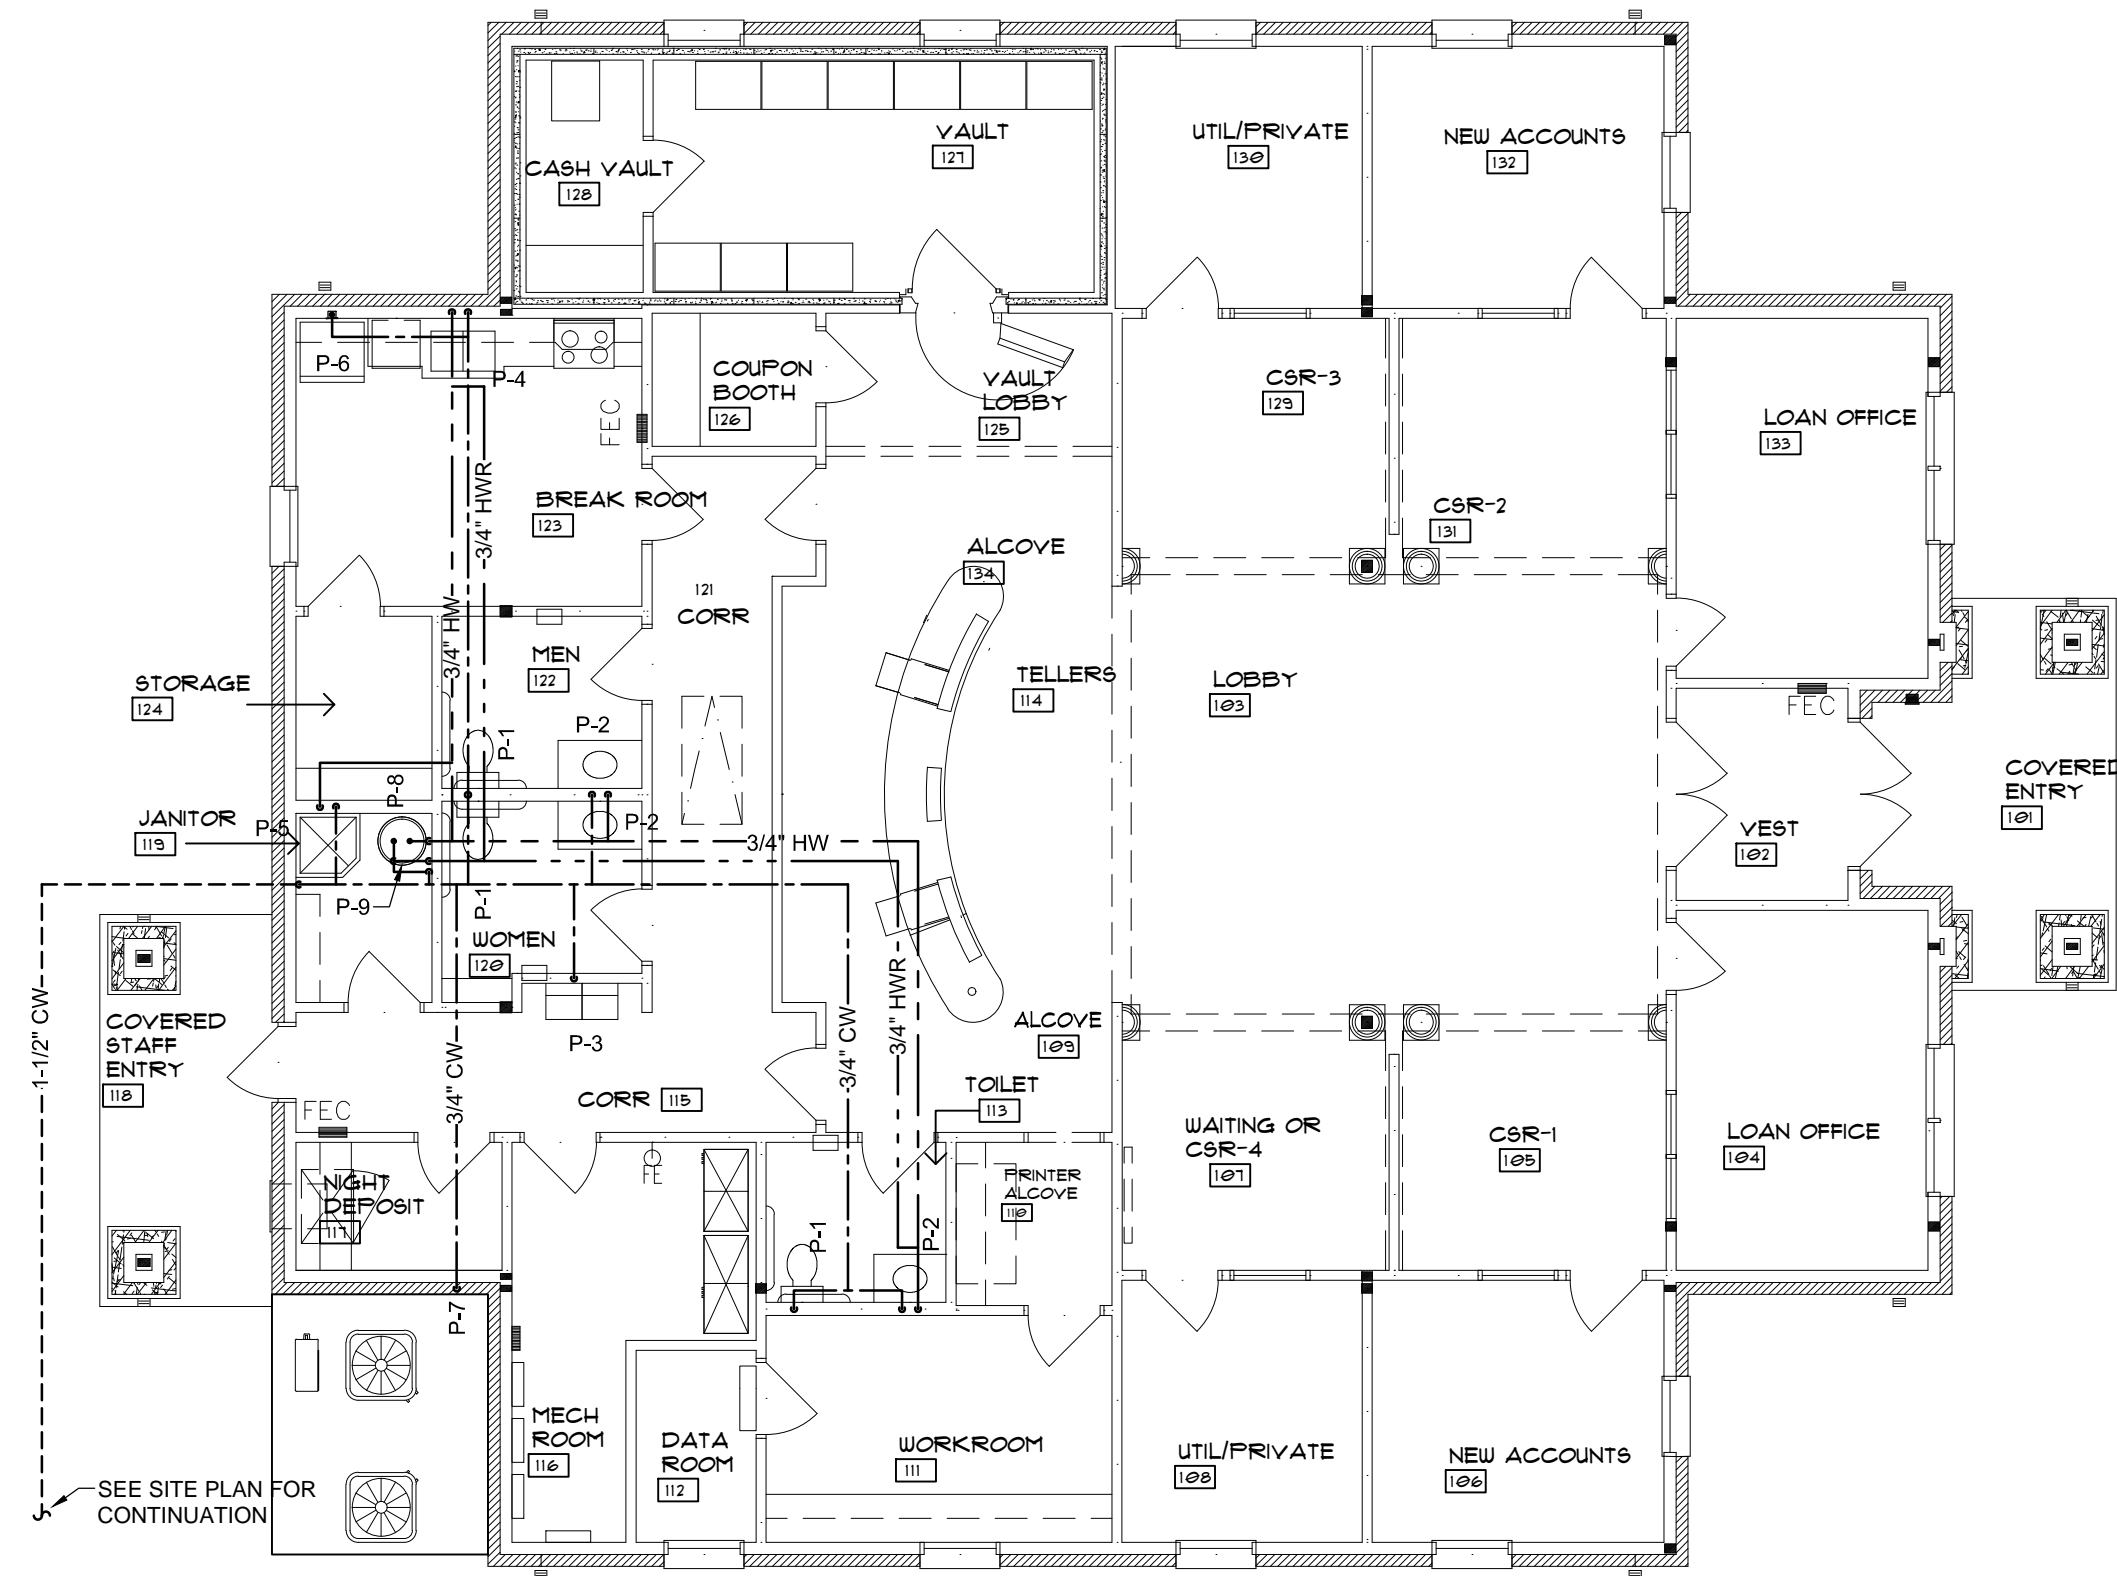

NEW CONSTRUCTION - WASTE AND VENT
PLUMBING FLOOR PLAN
SCALE: 1/8" = 1'-0"

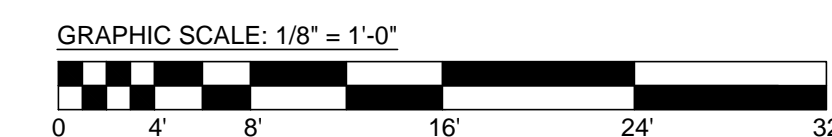

LAMBERT • EZELL • DURHAM
ARCHITECTURE, LLC
P.O. BOX 334 401 EAST COLLEGE ST. FLORENCE, ALABAMA 36631
TELEPHONE (256) 161-1100 WWW.LEDARCHITECTURE.COM

BRANCH BANK FOR
TRADERS AND FARMERS BANK
DOUBLE STRINGS, ALABAMA

JOB NO.	1612	DATE	11/30/17
DRAWN	IJB	REVISED	
CHECKED	JNE	REVISED	

DRAWING TITLE
PLUMBING FLOOR & ROOF PLAN

DRAWING NUMBER
P-2.0
OF 4